
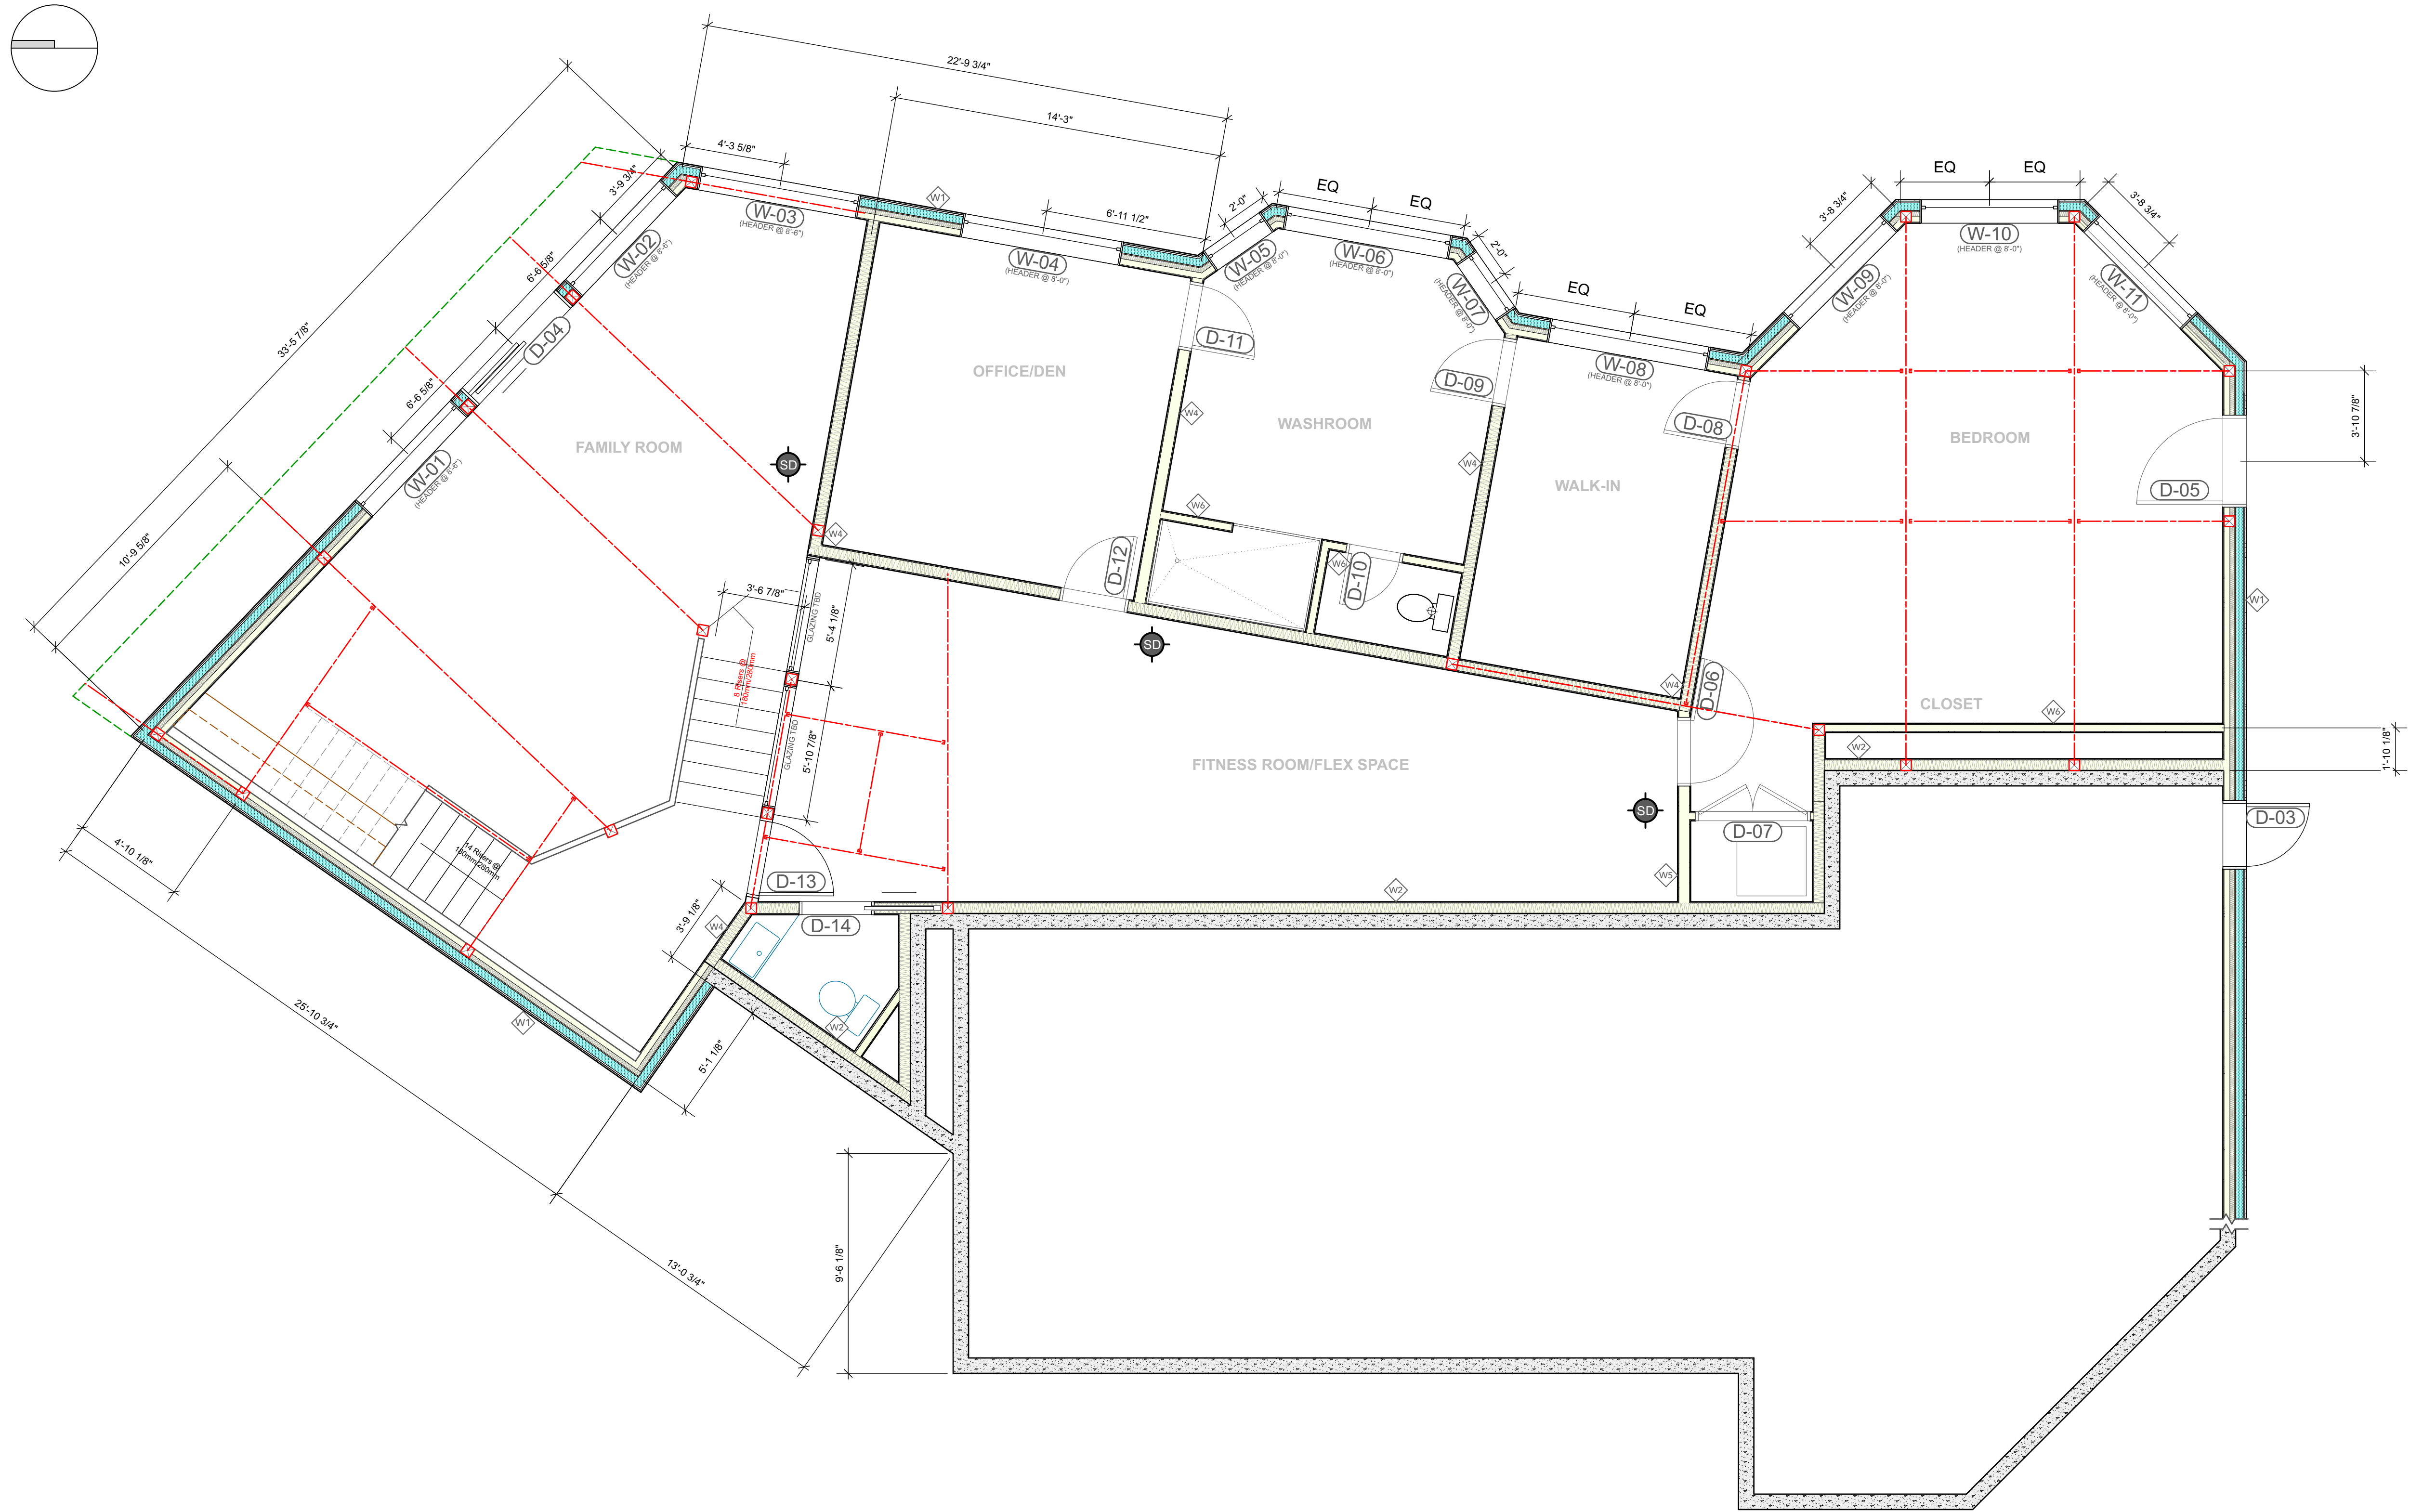


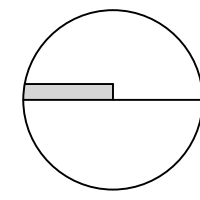

INDEX

PARTITION PLAN

- ID-1.01 LOWER FLOOR
- ID-1.02 MAIN FLOOR

REFLECTED CEILING PLAN

- ID-2.01 LOWER FLOOR
- ID-2.02 MAIN FLOOR

ELECTRICAL PLAN

- ID-3.01 LOWER FLOOR
- ID-3.02 MAIN FLOOR

FLOOR FINISHES

- ID-4.01 LOWER FLOOR
- ID-4.02 MAIN FLOOR


LOWER FLOOR

- ID-5.01 FAMILY ROOM & POWDER BATHROOM
- ID-5.02 PRIMARY ENSUITE

MAIN FLOOR

- ID-6.01 KITCHEN
- ID-6.02 KITCHEN ISLAND
- ID-6.03 PANTRY & POWDER BATHROOM
- ID-6.04 BATHROOM 1 & 2
- ID-6.05 LAUNDRY ROOM

1 Lower Floor - Partition Plan
Scale: 1/4" = 1'-0"

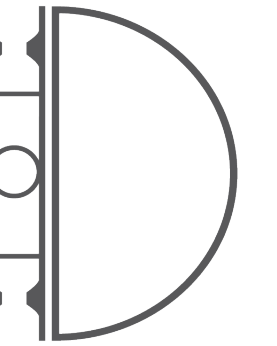

DESIGN
DISTRICT

DESIGN DISTRICT VICTORIA
577 PEMBROKE ST
VICTORIA, B.C V8T 1H3
250-590-8598

IT IS THE RESPONSIBILITY OF THE
CONTRACTOR TO CHECK AND
CONFIRM ALL DRAWINGS, DETAILS
AND SPECIFICATIONS PRIOR TO THE
COMMENCEMENT OF ANY PRODUCT
ORDERING, PRODUCTION OR
LABOUR AND REPORT ANY ERRORS,
OMISSIONS AND DISCREPANCIES TO
THE DESIGNER. IN ADDITION, ALL
MEASUREMENTS MUST BE
CONFIRMED ONSITE.

PROJECT NAME:
ASPREY RESIDENCE

PROJECT ADDRESS:
4351 GORDON HEAD RD

TITLE:
Lower Floor -
Partition Plan

DRAWN BY:
THUY GIRLING

ISSUE FOR:



DATE	DESCRIPTION

REVISION/NOTES:

DATE	DESCRIPTION

DATE: 2022-02-08
SCALE:

ID-3.02

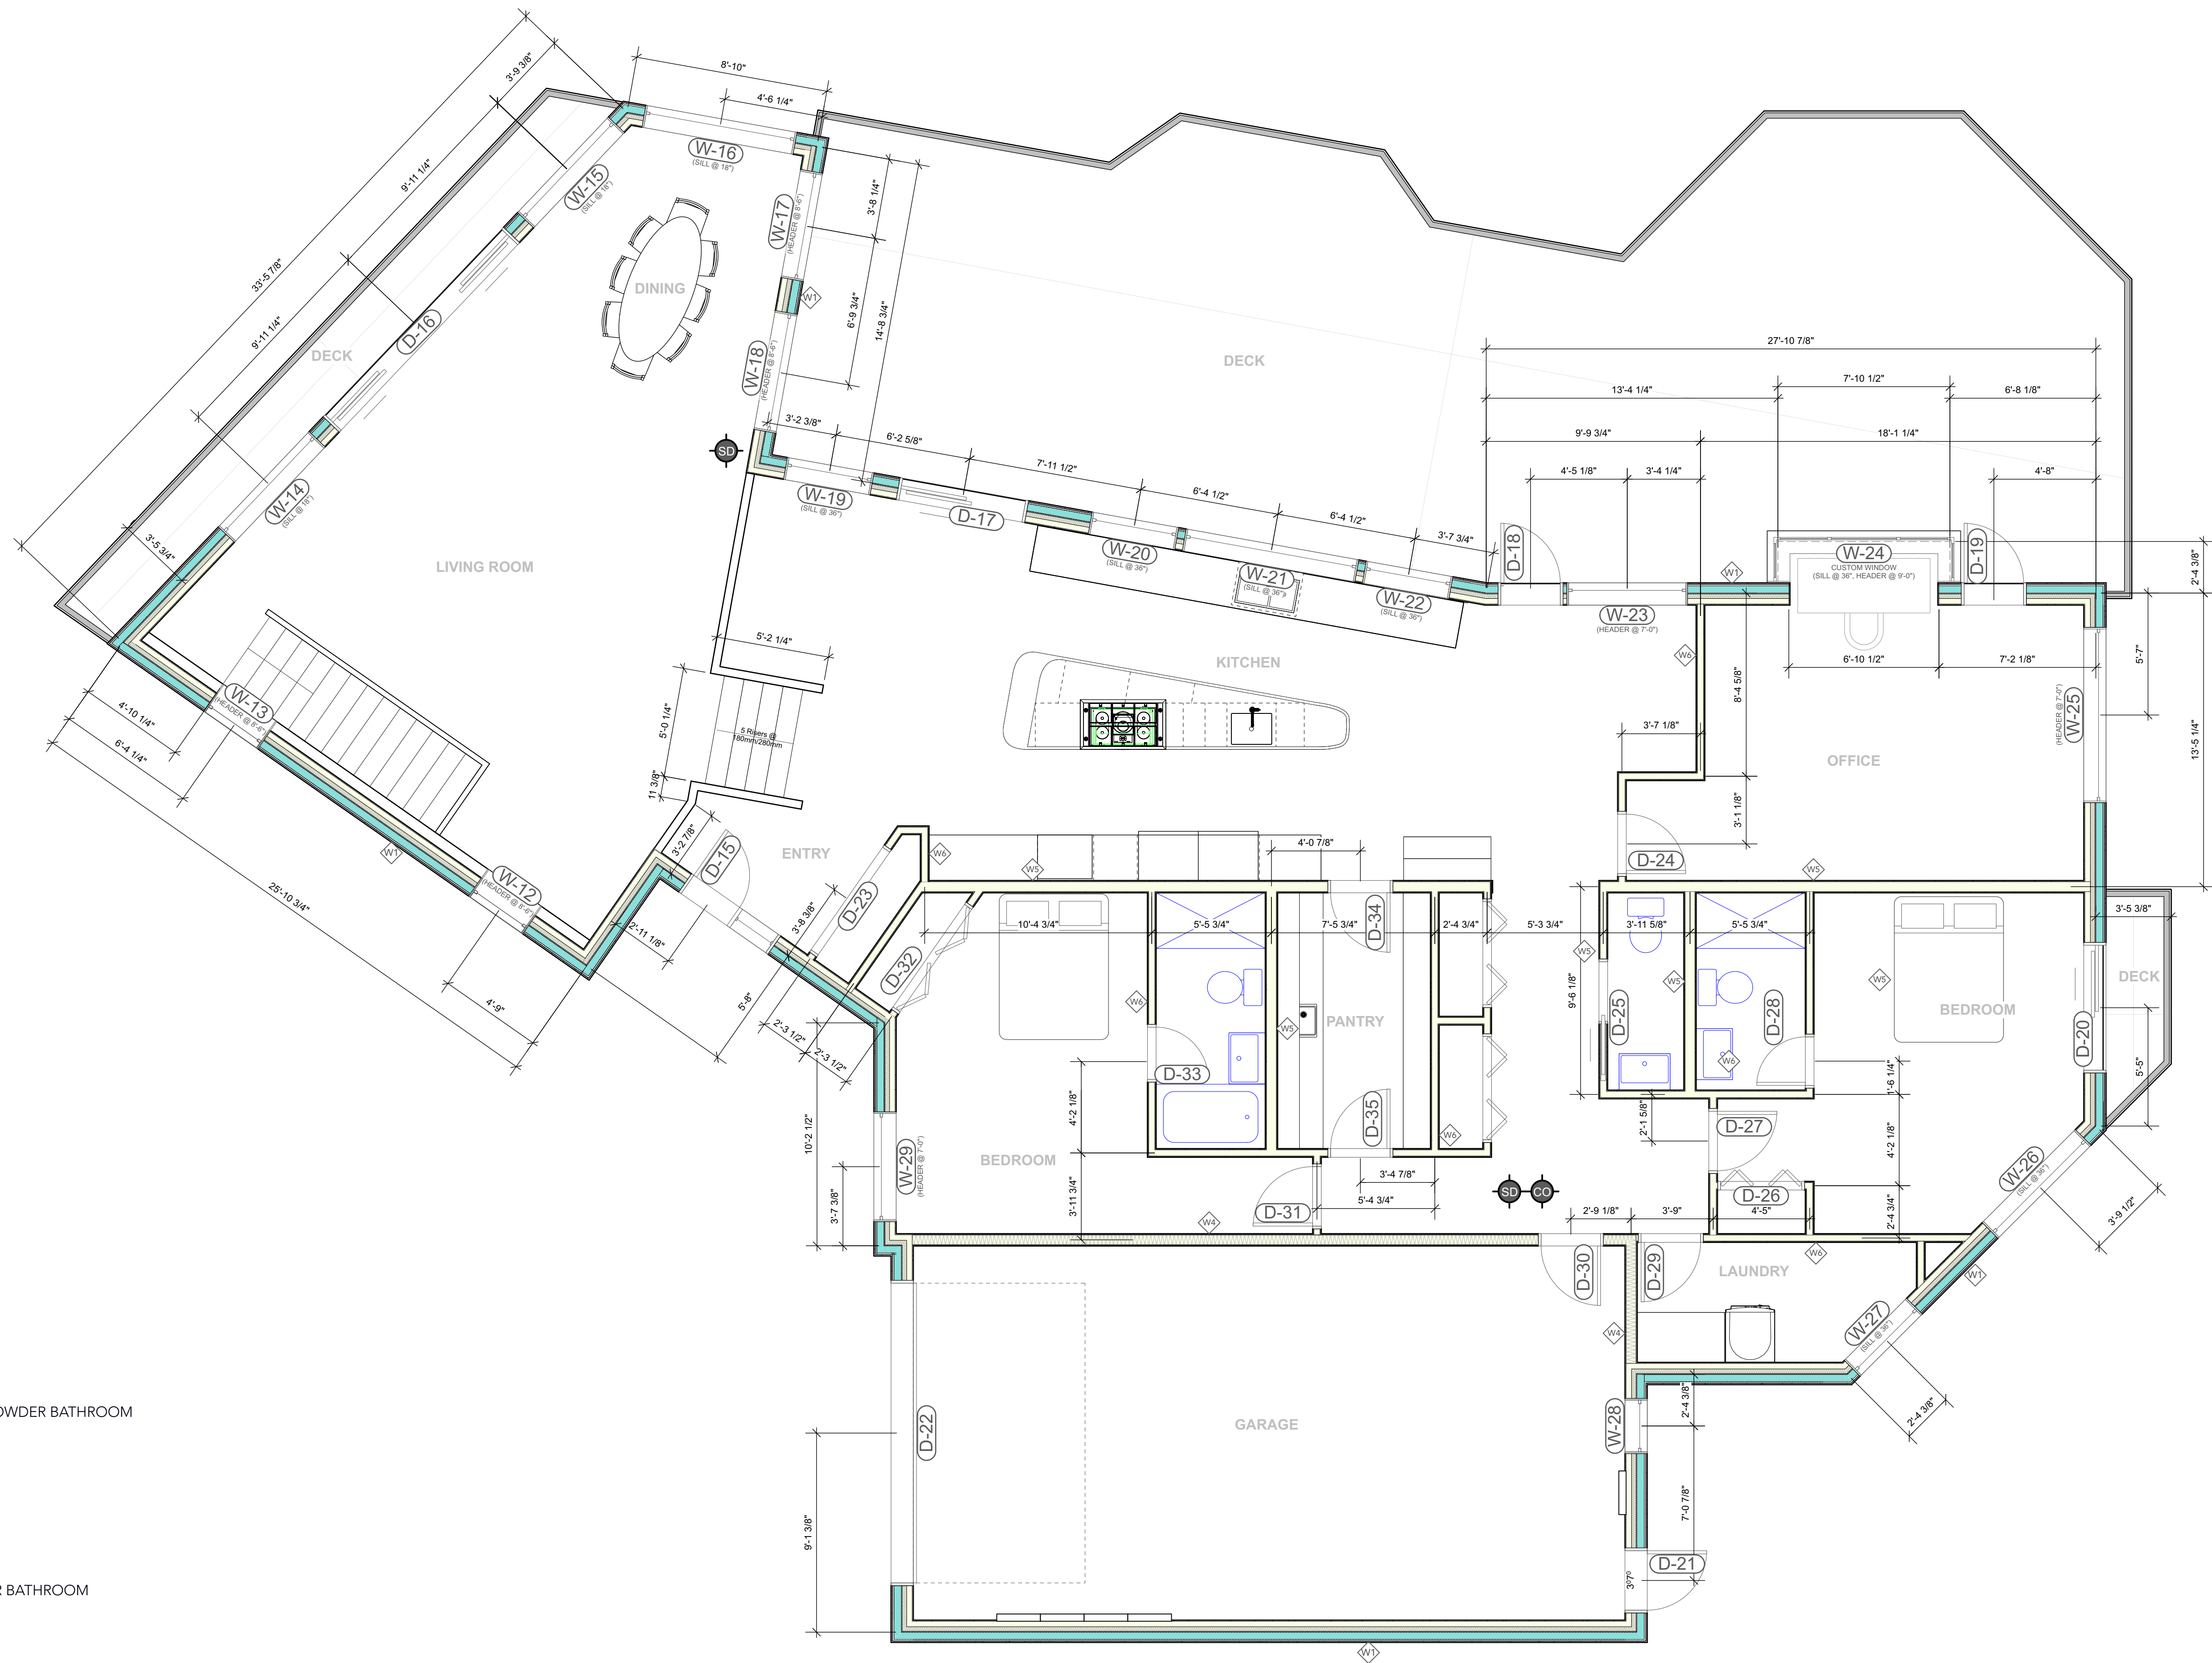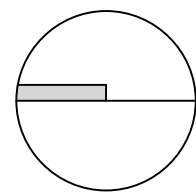

INDEX

PARTITION PLAN

- ID-1.01 LOWER FLOOR
- ID-1.02 MAIN FLOOR

REFLECTED CEILING PLAN

- ID-2.01 LOWER FLOOR
- ID-2.02 MAIN FLOOR

ELECTRICAL PLAN

- ID-3.01 LOWER FLOOR
- ID-3.02 MAIN FLOOR

FLOOR FINISHES

- ID-4.01 LOWER FLOOR
- ID-4.02 MAIN FLOOR


LOWER FLOOR

- ID-5.01 FAMILY ROOM & POWDER BATHROOM
- ID-5.02 PRIMARY ENSUITE

MAIN FLOOR

- ID-6.01 KITCHEN
- ID-6.02 KITCHEN ISLAND
- ID-6.03 PANTRY & POWDER BATHROOM
- ID-6.04 BATHROOM 1 & 2
- ID-6.05 LAUNDRY ROOM

1 Main Floor - Partition Plan
Scale: 1/4" = 1'-0"

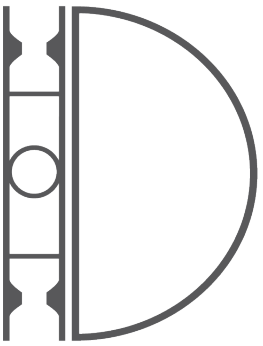

DESIGN
DISTRICT

DESIGN DISTRICT VICTORIA
577 PEMBROKE ST
VICTORIA, B.C V8T 1H3
250-590-8598

IT IS THE RESPONSIBILITY OF THE
CONTRACTOR TO CHECK AND
CONFIRM ALL DRAWINGS, DETAILS
AND SPECIFICATIONS PRIOR TO THE
COMMENCEMENT OF ANY PRODUCT
ORDERING, PRODUCTION OR
LABOUR AND REPORT ANY ERRORS,
OMISSIONS AND DISCREPANCIES TO
THE DESIGNER. IN ADDITION, ALL
MEASUREMENTS MUST BE
CONFIRMED ONSITE.

PROJECT NAME:
ASPREY RESIDENCE

PROJECT ADDRESS:
4351 GORDON HEAD RD

TITLE:
Main Floor -
Partition Plan

DRAWN BY:
THUY GIRLING

ISSUE FOR:

DATE	DESCRIPTION

REVISION/NOTES:

DATE	DESCRIPTION

DATE: 2022-02-08
SCALE:

ID-1.02